


总平面位置示意图 MASTER KEY PLAN		
设计说明 DESIGN CONTENT		
所有设计。图纸及说明之版权全属本公司所有。除非得本公司书面同意，否则不得使用抄袭及复制。所有尺寸需作实地检查复核，不可以图纸尺寸量度为准。所有图纸以最后修改为准。  All design drawings specifications are copyright and can not be used copied or reproduced without the prior written form acceptance of our company.All measurement must be checked on site. Do not scale drawing. Drawing not showing latest revisions are to be cancelled. See colour scheme chart for material finishes and speoication. Manufacturer shall prepare "shop drawing or prototype samples" for this item and submit them to the designer for checking and approval.		
修改： REVISION		
项目名称 PROJECT		
运动生理学实验室		
阶段 STAGE		
图纸名称 DRAWING TITLE		
工程编号 JOB NO.		
比例 SCALE		
日期 DATE		
设计主持 M. DESIGNER		
审定 APPROVED BY		
审核 APPROVED BY		
校对 CHECKED BY		
设计师 DESIGNER		
制图 DRAWER		
图纸编号 DWG No.		
页码 SHEET No.		

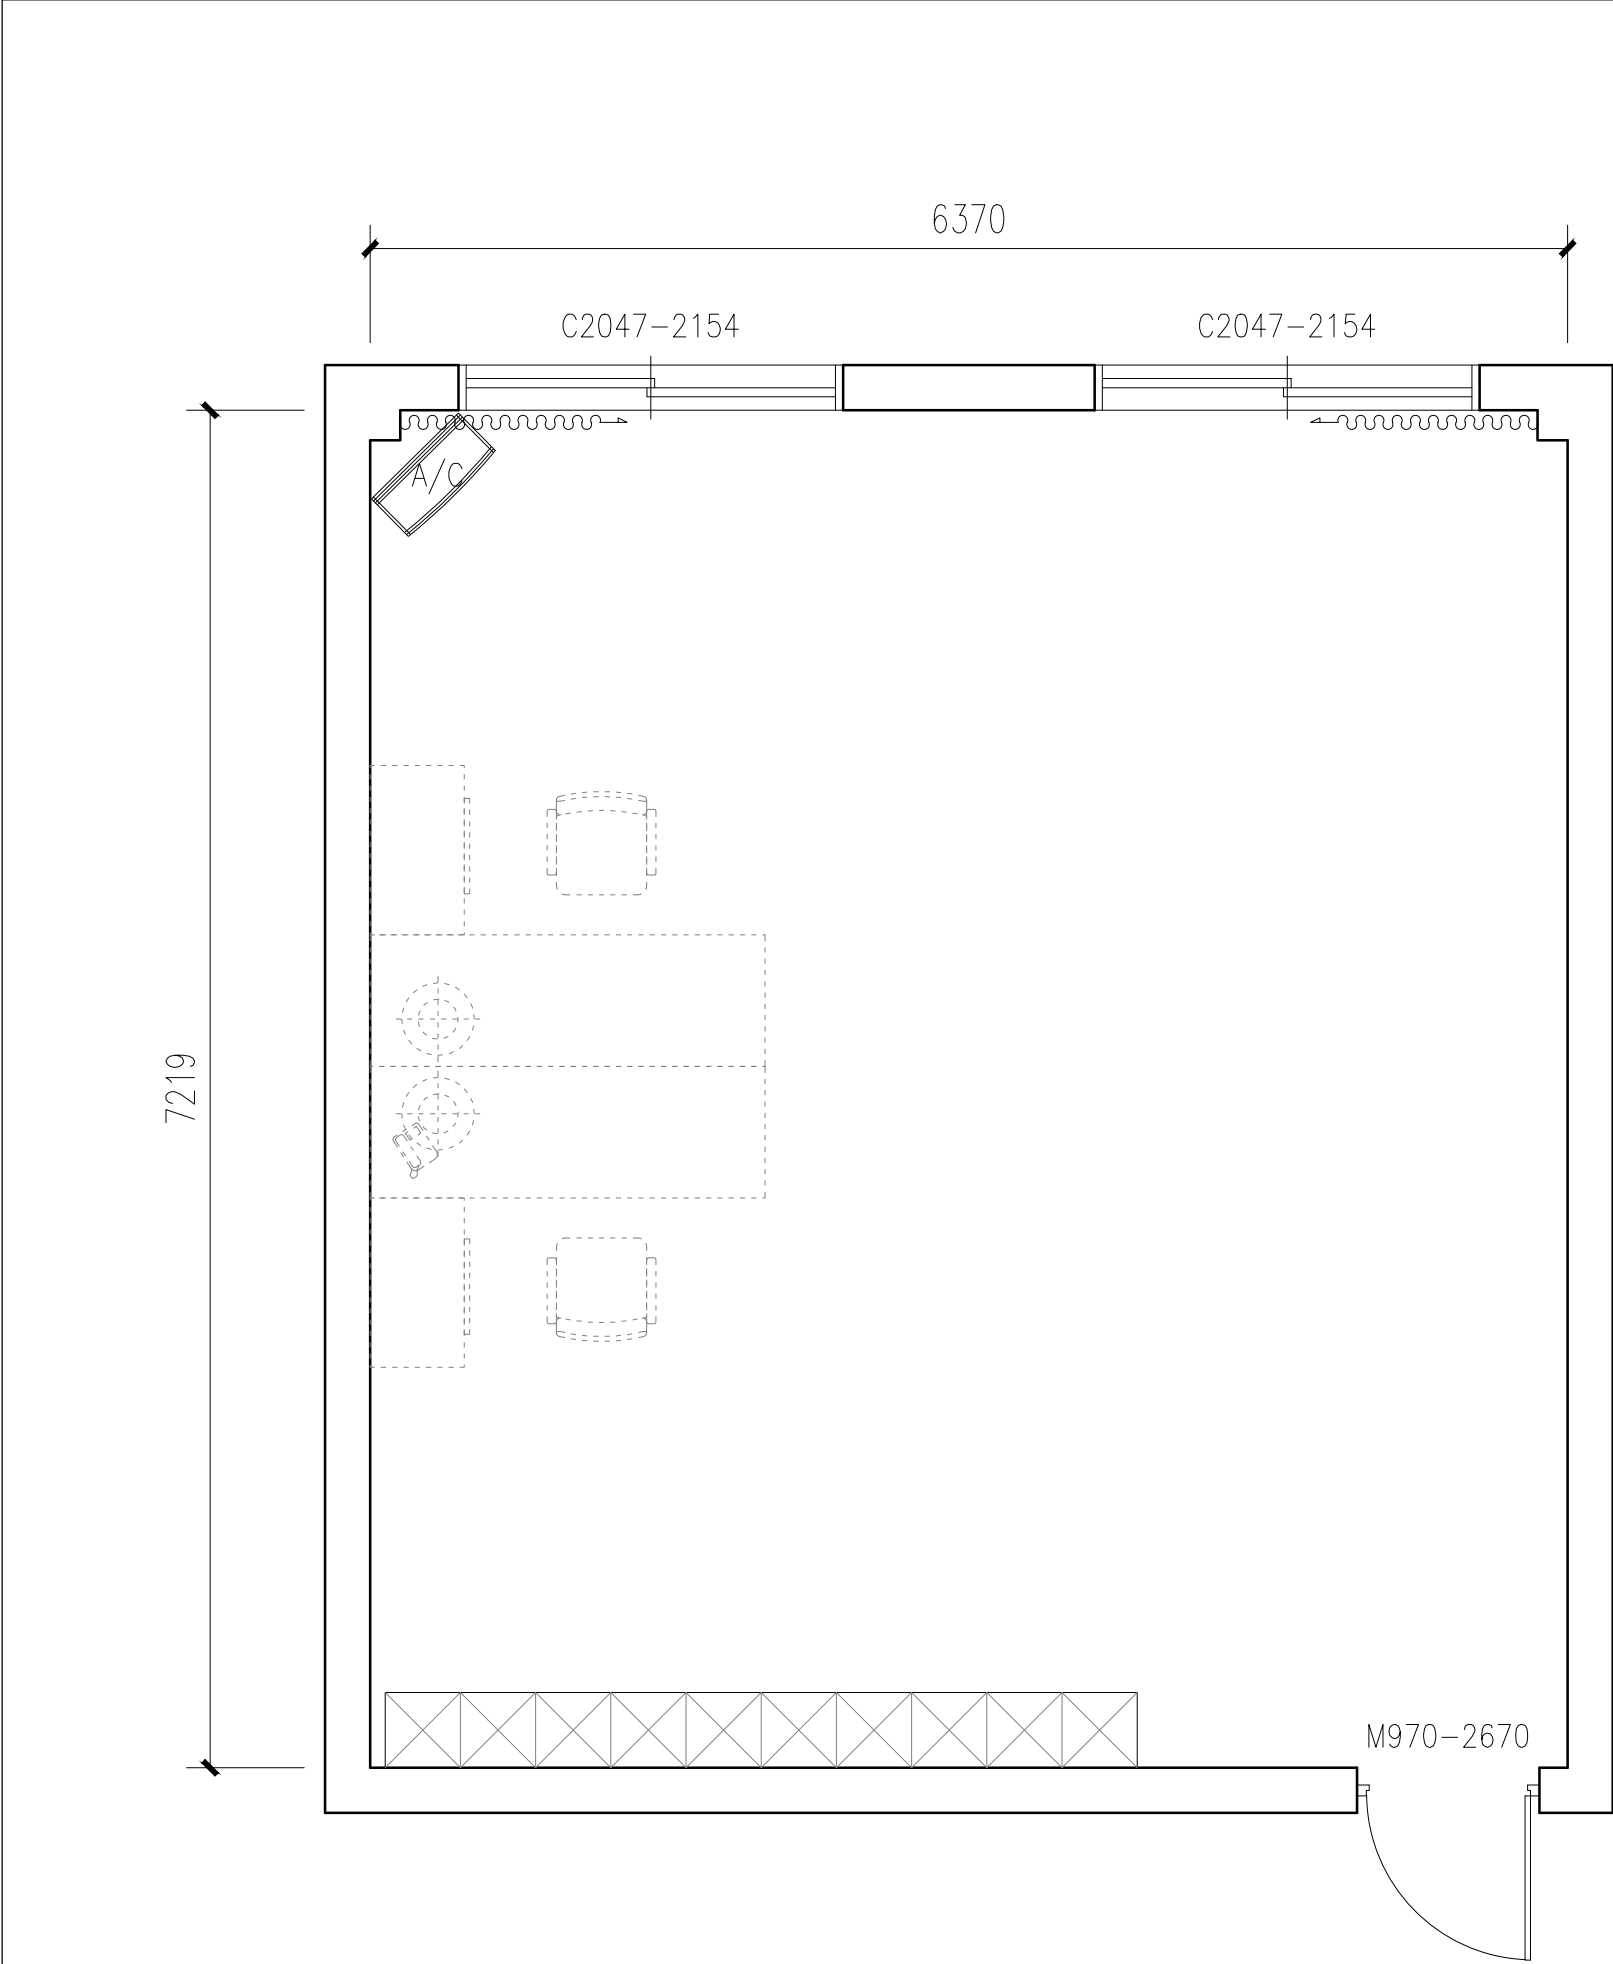

- 施工内容：
- 1、铲除踢脚线粉水泥砂浆
  - 2、拆换防盗门，砌粉门洞，新装防盗门M970-2050,电子门禁锁
  - 3、铲除墙面涂料层，抗裂网格布，批刮腻子两遍，刷白色乳胶漆两遍
  - 4、地面水泥基自流平，铺贴2mm厚同质透心塑胶地板
  - 5、原顶砂磨喷黑色乳胶漆，吊装铝格栅顶
  - 6、制作橱柜，下柜门上玻璃门
  - 7、新装配电箱，改造线路，安装六盏600\*600LED嵌装灯

01  
FF-01

平面布置图

EXISTING PLAN

SCALE 1:40

总平面位置示意图  
MASTER KEY PLAN

设计说明  
DESIGN CONTENT

所有设计，图纸及说明之版权全属本公司所有。除非  
得本公司书面同意，否则不得使用抄袭及复制。所有  
尺寸需作实地检查复核，不可以图纸尺寸量度为准。  
所有图纸以最后修改为准。

All design drawings specifications are copyright  
and can not be used copied or reproduced with-  
out the prior written form acceptance of our  
company.All measurement must be checked on site.  
Do not scale drawing.Drawing not showing latest  
revisions are to be cancelled.See colour scheme  
chart for material finishes and speoication.  
Manufacturer shall prepare "shop drawing or  
prototype samples"for this item and submit them  
to the designer for checking and approval.

修改：  
REVISION

项目名称  
PROJECT

运动生理学实验室

阶段  
STAGE

图纸名称  
DRAWING TITLE

工程编号  
JOB NO.

比例  
SCALE

日期  
DATE

设计主持  
M. DESIGNER

审定  
APPROVED BY

审核  
APPROVED BY

校对  
CHECKED BY

设计师  
DESIGNER


制图  
DRAWER

图纸编号  
DWG No.

页码  
SHEET No.

归档文件：



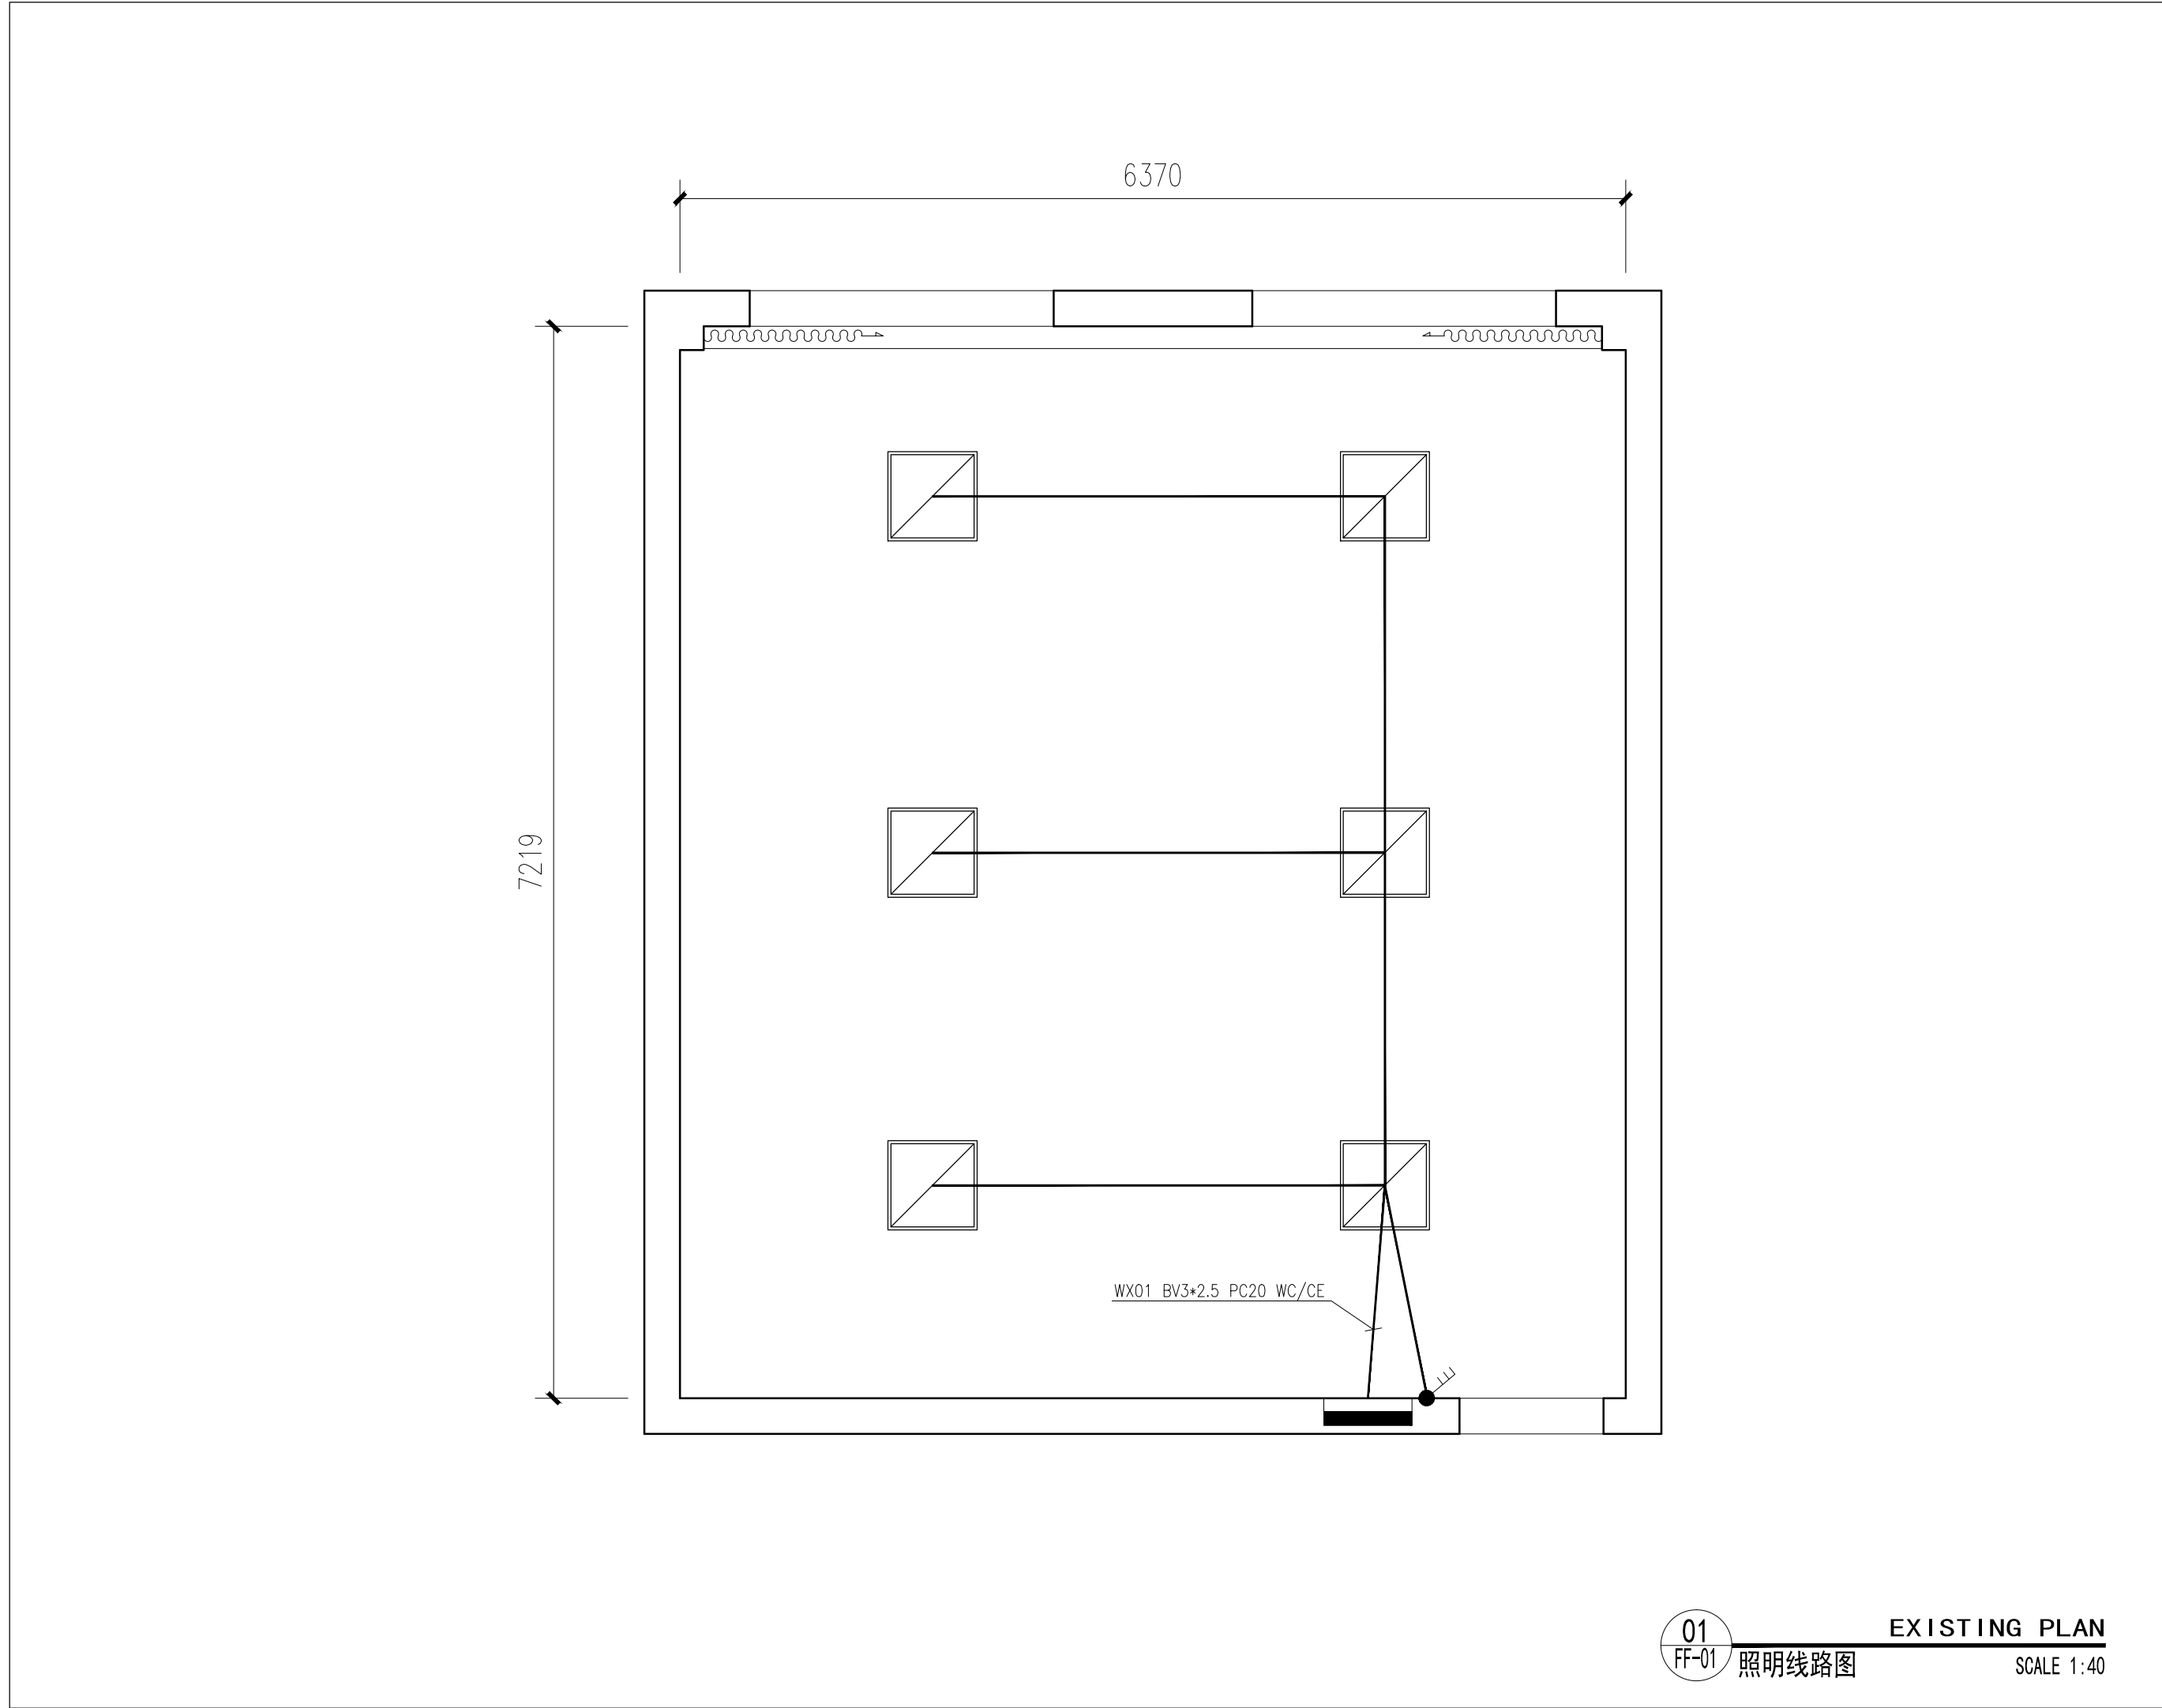

总平面图位置示意图 MASTER KEY PLAN		
设计说明 DESIGN CONTENT		
所有设计、图纸及说明之版权全属本公司所有。除非得本公司书面同意，否则不得使用抄袭及复制。所有尺寸需作实地检查复核，不可以图纸尺寸量度为准。所有图纸以最后修改为准。 All design drawings specifications are copyright and can not be used copied or reproduced without the prior written form acceptance of our company. All measurement must be checked on site. Do not scale drawing. Drawing not showing latest revisions are to be cancelled. See colour scheme chart for material finishes and specification. Manufacturer shall prepare "shop drawing or prototype samples" for this item and submit them to the designer for checking and approval.		
修改： REVISION		
项目名称 PROJECT		
运动生理学实验室		
阶段 STAGE		
图纸名称 DRAWING TITLE		
工程编号 JOB NO.		
比例 SCALE		
日期 DATE		
设计主持 M. DESIGNER		
审定 APPROVED BY		
审核 APPROVED BY		
校对 CHECKED BY		
设计师 DESIGNER		
制图 DRAWER		
图纸编号 DWG No.		
页码 SHEET No.		


01  
FF-01

照明线路图


EXISTING PLAN

SCALE 1:40

归档文件:

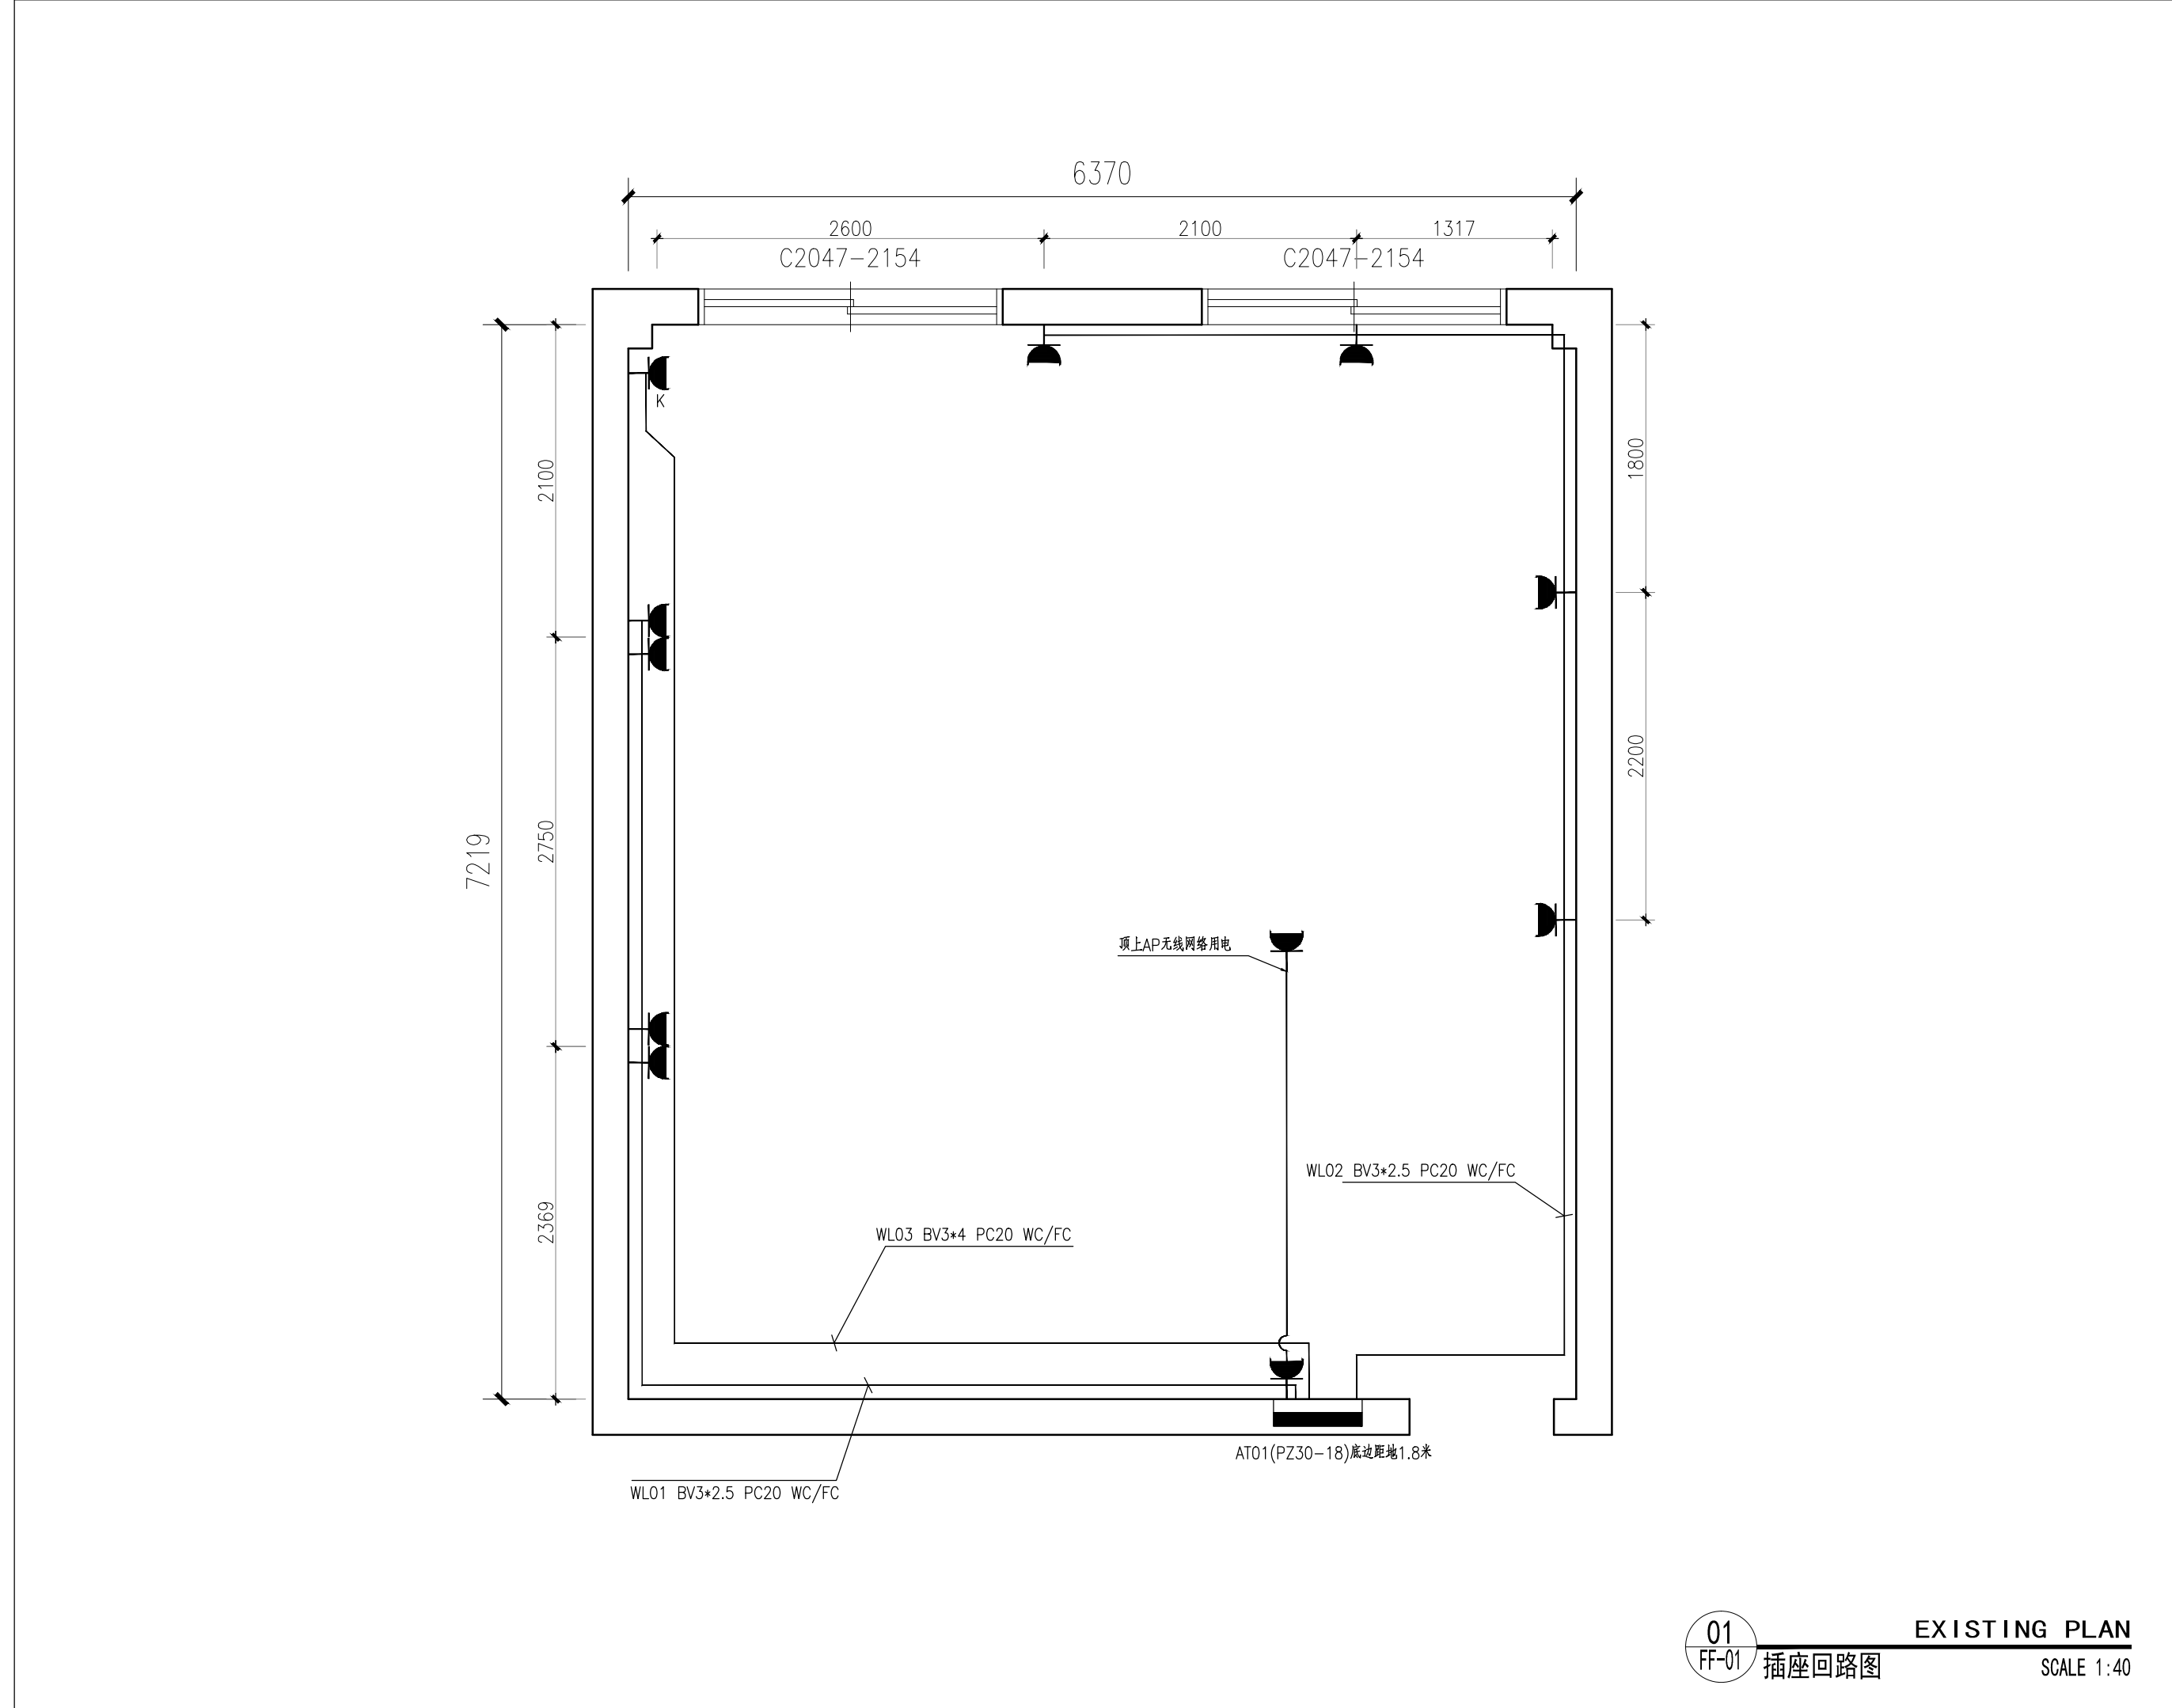

总平面位置示意图 MASTER KEY PLAN		
设计说明 DESIGN CONTENT		
所有设计，图纸及说明之版权全属本公司所有。除非 得本公司书面同意，否则不得使用抄袭及复制。所有 尺寸需作实地检查复核，不可以图纸尺寸量度为准。 所有图纸以最后修改为准。  All design drawings specifications are copyright and can not be used copied or reproduced with- out the prior written form acceptance of our company.All measurement must be checked on site. Do not scale drawing.Drawing not showing latest revisions are to be cancelled.See colour scheme chart for material finishes and speoication. Manufacturer shall prepare "shop drawing or prototype samples"for this item and submit them to the designer for checking and approval.		
修改： REVISION		
项目名称 PROJECT		
运动生理学实验室		
阶段 STAGE		
图纸名称 DRAWING TITLE		
工程编号 JOB NO.		
比例 SCALE		
日期 DATE		
设计主持 M. DESIGNER		
审定 APPROVED BY		
审核 APPROVED BY		
校对 CHECKED BY		
设计师 DESIGNER		
制图 DRAWER		
图纸编号 DWG No.		
页码 SHEET No.		

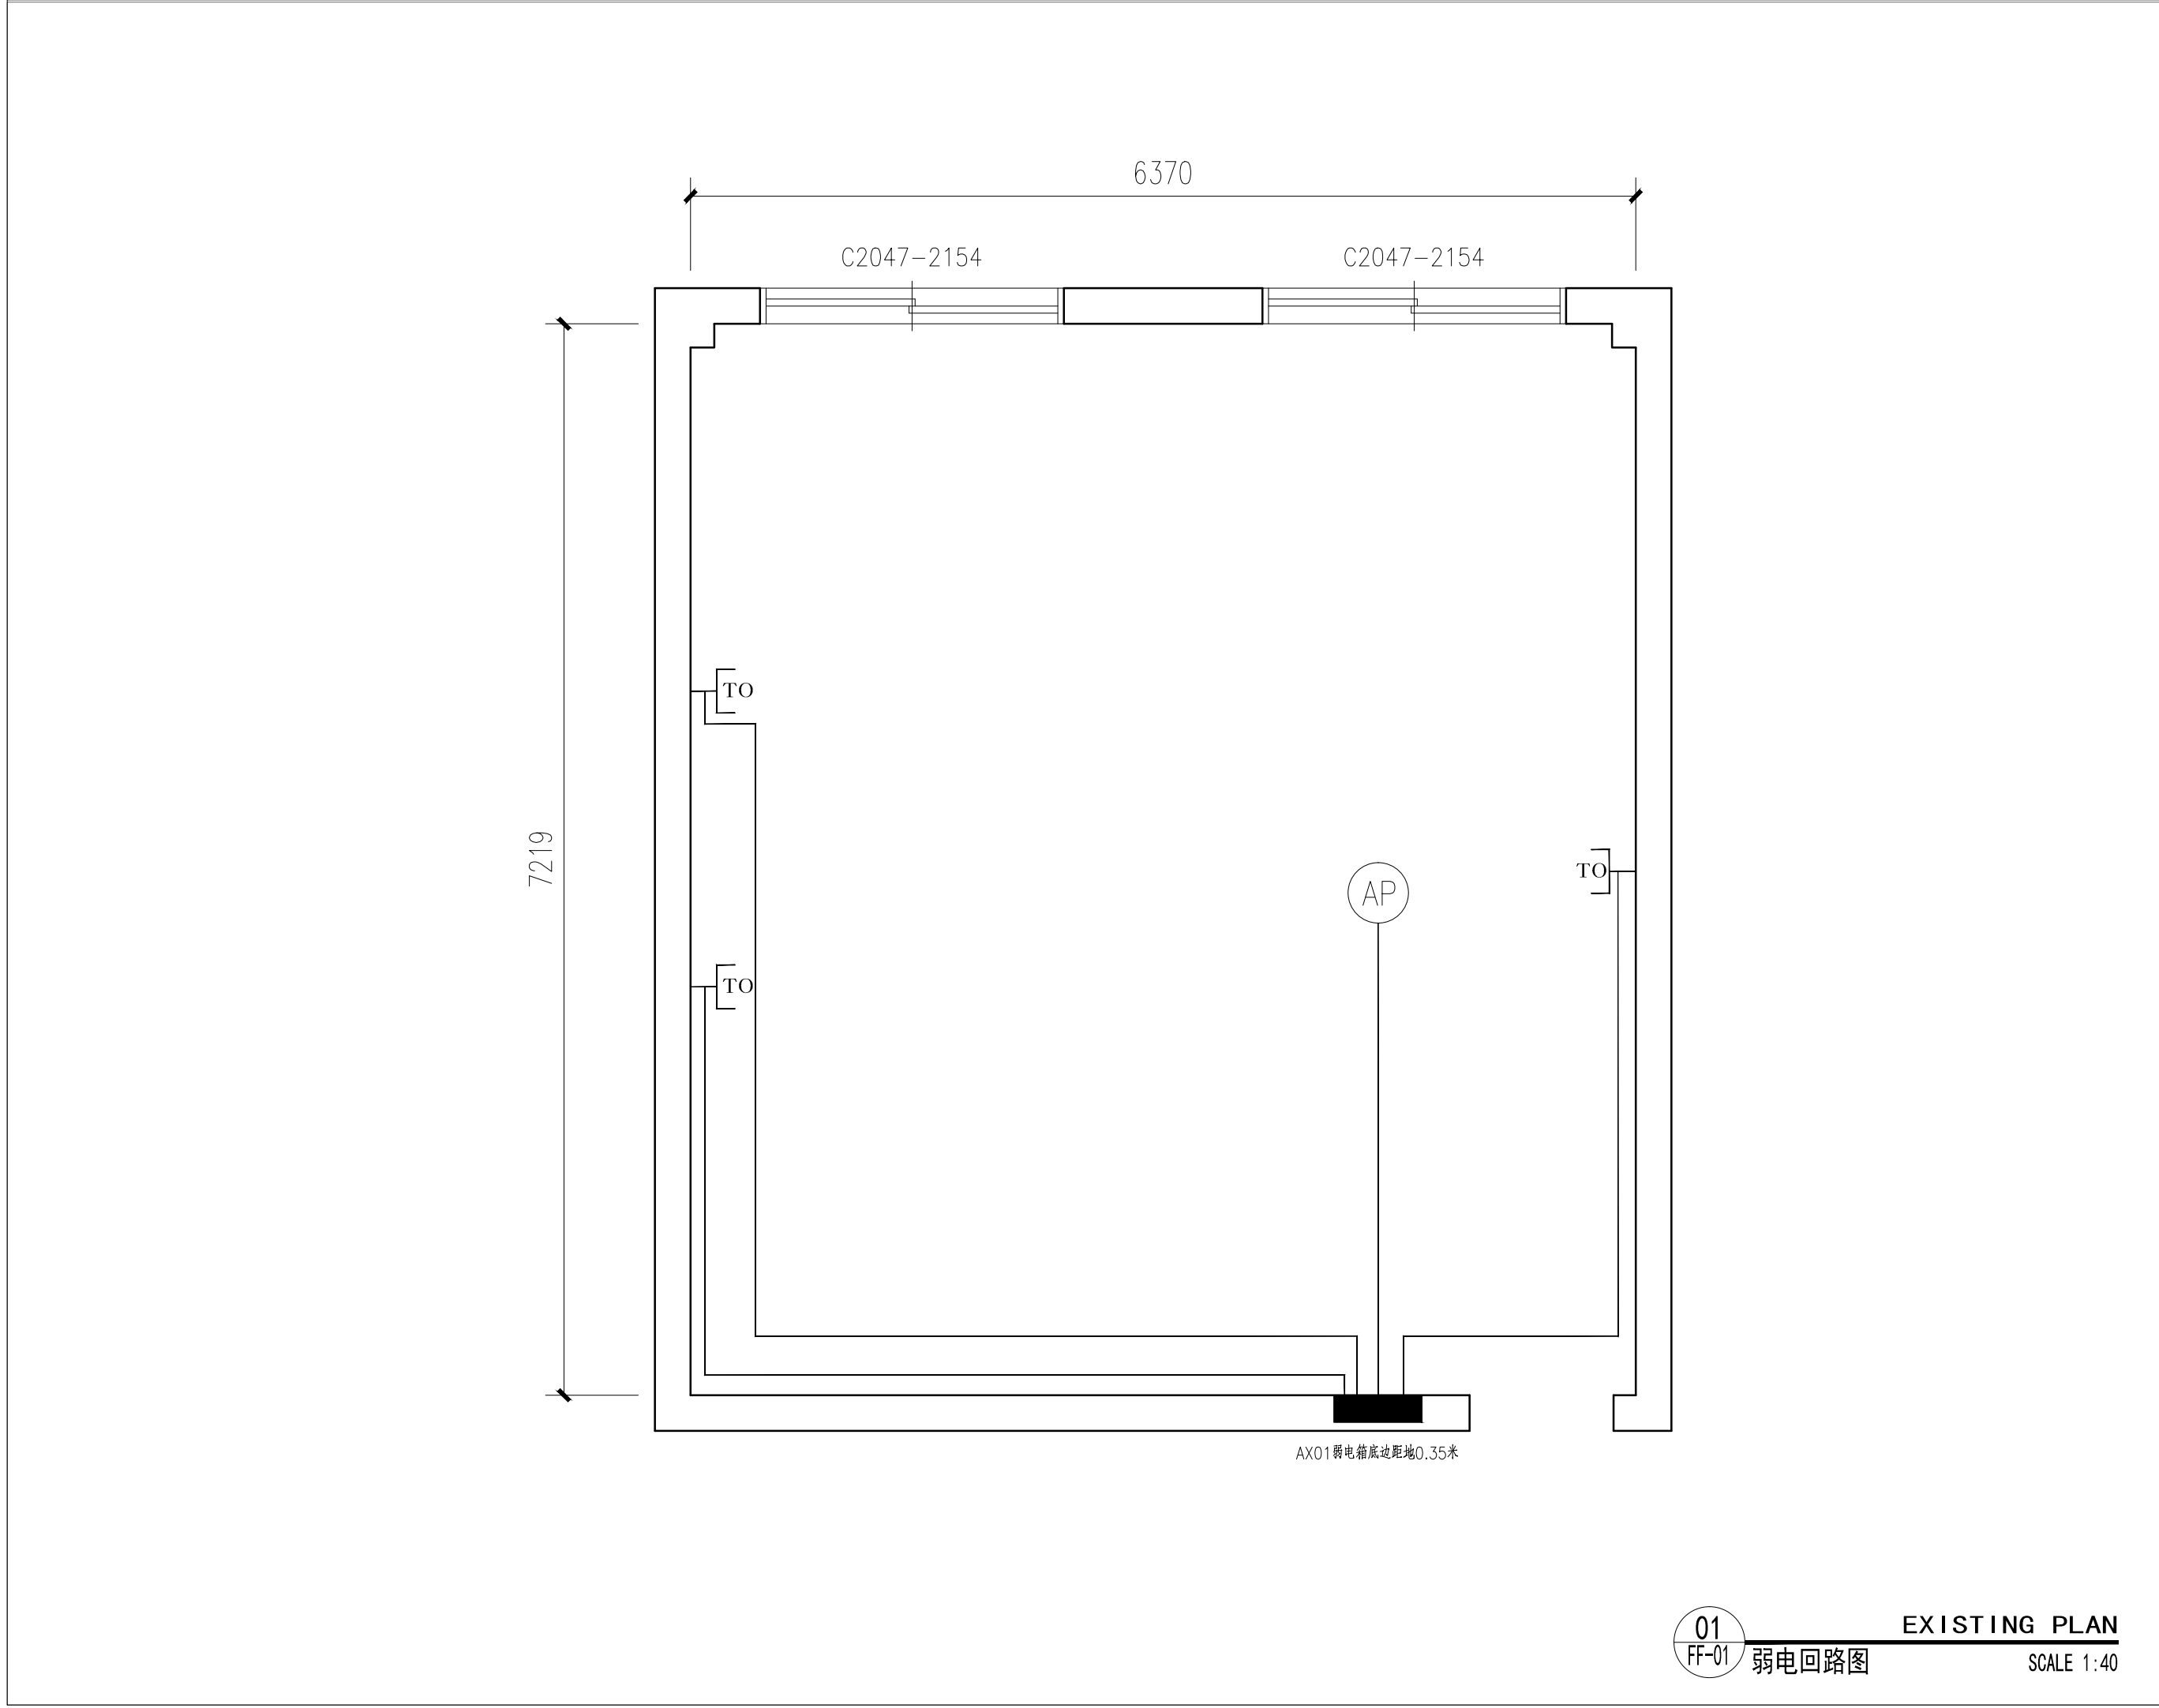

总平面位置示意图 MASTER KEY PLAN		
设计说明 DESIGN CONTENT		
所有设计、图纸及说明之版权全属本公司所有。除非得本公司书面同意，否则不得使用抄袭及复制。所有尺寸需作实地检查复核，不可以图纸尺寸量度为准。所有图纸以最后修改为准。 All design drawings specifications are copyright and can not be used copied or reproduced without the prior written form acceptance of our company. All measurement must be checked on site. Do not scale drawing. Drawing not showing latest revisions are to be cancelled. See colour scheme chart for material finishes and specification. Manufacturer shall prepare "shop drawing or prototype samples" for this item and submit them to the designer for checking and approval.		
修改： REVISION		
项目名称 PROJECT		
运动生理学实验室		
阶段 STAGE		
图纸名称 DRAWING TITLE		
工程编号 JOB NO.		
比例 SCALE		
日期 DATE		
设计主持 M. DESIGNER		
审定 APPROVED BY		
审核 APPROVED BY		
校对 CHECKED BY		
设计师 DESIGNER		
制图 DRAWER		
图纸编号 DWG No.		
页码 SHEET No.		

01  
FF-01

弱电回路图

EXISTING PLAN

SCALE 1:40

归档文件: